


- Concrete Sidewalk 5'-00" Wide 89 LF
- Cement Pavers 1,173 SF
- Untitled 11,043 SF
- Untitled 3,984 SF
- Aluminum Screen Enclosure 27 LF

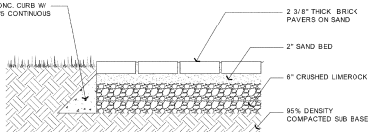

SITE PLAN - NEW
SCALE: 1/8" = 1'-0"



ZONING INFORMATION

PROPERTY ADDRESS: 6510 SAN VICENTE STREET, CORAL GABLES, FL 33146

LOT SIZE 105.06' X 105.06' = 11,037 SF

LOT COVERAGE MAXIMUM ALLOWED: 36% = 3,982 SF PROVIDED: 3,856 SF

HEIGHT ALLOWED: 20' PROVIDED: 22'-6" +/-

SET BACKS: Required FRONT 25' REAR 10' SIDE 20% Frontage = 21' Provided FRONT 25'-2" REAR 12'-11" SIDE 12' and 18'-4"

FLOOD PROGRAM LEGEND

FLOOD ZONE "X" COMMUNITY R/O 120639 PANEL NUMBER 0459 SUFFIX 09/11/2009

BENCH MARK USED: CITY OF CORAL GABLES BENCH MARK No. 215 ELEV. = 10.24' NGVD.

LEGAL DESCRIPTION

LOTS 7 AND 8, BLOCK 284, OF REVISED PLAT OF CORAL GABLES, RIVERSIDE SECTION, PART 11, ACCORDING TO THE PLAT THEREOF, RECORDED IN PLAT BOOK 28, PAGE 23 OF THE PUBLIC RECORDS OF MIAMI-DADE COUNTY, FLORIDA.

PROPERTY ADDRESS: 6510 SAN VICENTE STREET, CORAL GABLES, FL 33146

STATEMENT OF COMPLIANCE

TO THE BEST OF MY KNOWLEDGE THESE DRAWINGS ARE COMPLETE, AND COMPLY WITH THE FLORIDA BUILDING CODE, 2010.

ARCHITEKTNICS
ARCHITECTS & PLANNERS

7450 Southwest 48th Street
Miami, Florida 33155
Phone (305) 661-5392
Fax (305) 661-5832
info@architektnics.com
License # AAC000546

www.architektnics.com

NEW RESIDENCE FOR:
MARLIN EBBERT

6510 SAN VICENTE STREET
CORAL GABLES, FLORIDA 33146

Project:

Edward C. Berounsky, R.A.
License Number: AR0000403

Drawing title:

SITE PLAN

Issue Date: Jan. 8, 2015

Revisions:

No.	Description	By	Date

Job No.: 14107
Drawn By:
Sheet No.:

A-1.1



7450 Southwest 48th Street
Miami, Florida 33155
Phone (305) 661-5392
Fax (305) 661-5832
info@architektnics.com
License # AAC000246

www.architektnics.com

NEW RESIDENCE FOR:
MARLIN EBBERT
6610 SAN VICENTE STREET
CORAL GABLES, FLORIDA 33146



Edward C. Rucinsky, P.E.
License Number: AR000043

Drawing title:


OVERALL
FLOOR PLAN -
NEW

Issue Date: Jan. 8, 2015
Revisions:

Job No.: 14107
Drawn By:
Sheet No.:

A-2.2


- Partition Framing - 2x4, @ 16" OC 205 LF
- Partition Framing - 2x8, @ 16" OC 64 LF
- Partition Framing - 2x PT Furring, @ 16" OC 514 LF
- AC Equipment Pads 57 SF
- Refrigerator 2 EA
- Dish Washer 1 EA
- Oven 1 EA
- Washing Machine 1 EA
- Microwave 1 EA
- Range Cooktop - 4 Burners 1 EA
- Dryer Machine 1 EA
- 1 - A - Alum/Glass White Kynar 3068 1/2 French Glass 2 Sidelights & Transom 1 EA
- 2 - F - 8090 Garage Doors w/ Glass Inserts 2 EA
- 3 - B - 3070 Metal 1 EA
- 4 - C - Alum/Glass W. K. (2) 2680 CGI French Door 1 EA
- 5 - D - Alum/Screen W. K. (2) 2670 CGI French Door 1 EA
- 6 - C - Alum/Glass W. K. (2) 2680 CGI French Door 1 EA
- 7 - C - Alum/Glass W. K. (2) 2680 CGI French Door 1 EA
- 8 - B - Wood 2880 1 EA
- 9 - E - Wood 3080 - bifold 1 EA
- 10 - H - Wood (2)3080 - mirrored glass slider 1 EA
- 11 - B - Wood 2880 1 EA
- 12 - G - Wood 3068 - pocket door 1 EA
- 13 - B Wood 3068 1 EA
- 14 - B Wood 2680 1 EA
- 15 - E Wood 2080 - bifold 1 EA
- 16 - H Wood 2080 1 EA
- 17 - G Wood 2080 - pocket door 1 EA
- 18 - G Wood 2080 1 EA
- 19 - J Wood 2880 1 EA
- 20 - B Wood 2680 1 EA
- 21 - E Wood 2080 - bifold 1 EA
- 22 - B Wood 2080 1 EA
- 23 - G Wood 2080 - pocket door 1 EA
- 24 - I Wood/Glass (2) 2480 Custom French 1 EA
- 25 - J Wood 11080 1 EA
- 26 - B - Wood 2868 1 EA
- 27 - K - Alum/Glass 3068 3 EA
- A - 24x54 23 EA
- B - 18x30 2 EA
- C - 20x20 5 EA
- D - 36 x Varies 1 EA
- E - 32x48 2 EA
- F - 20x54 4 EA
- G - 24x24 3 EA
- H - 30x30 1 EA
- I - 24" Round 1 EA

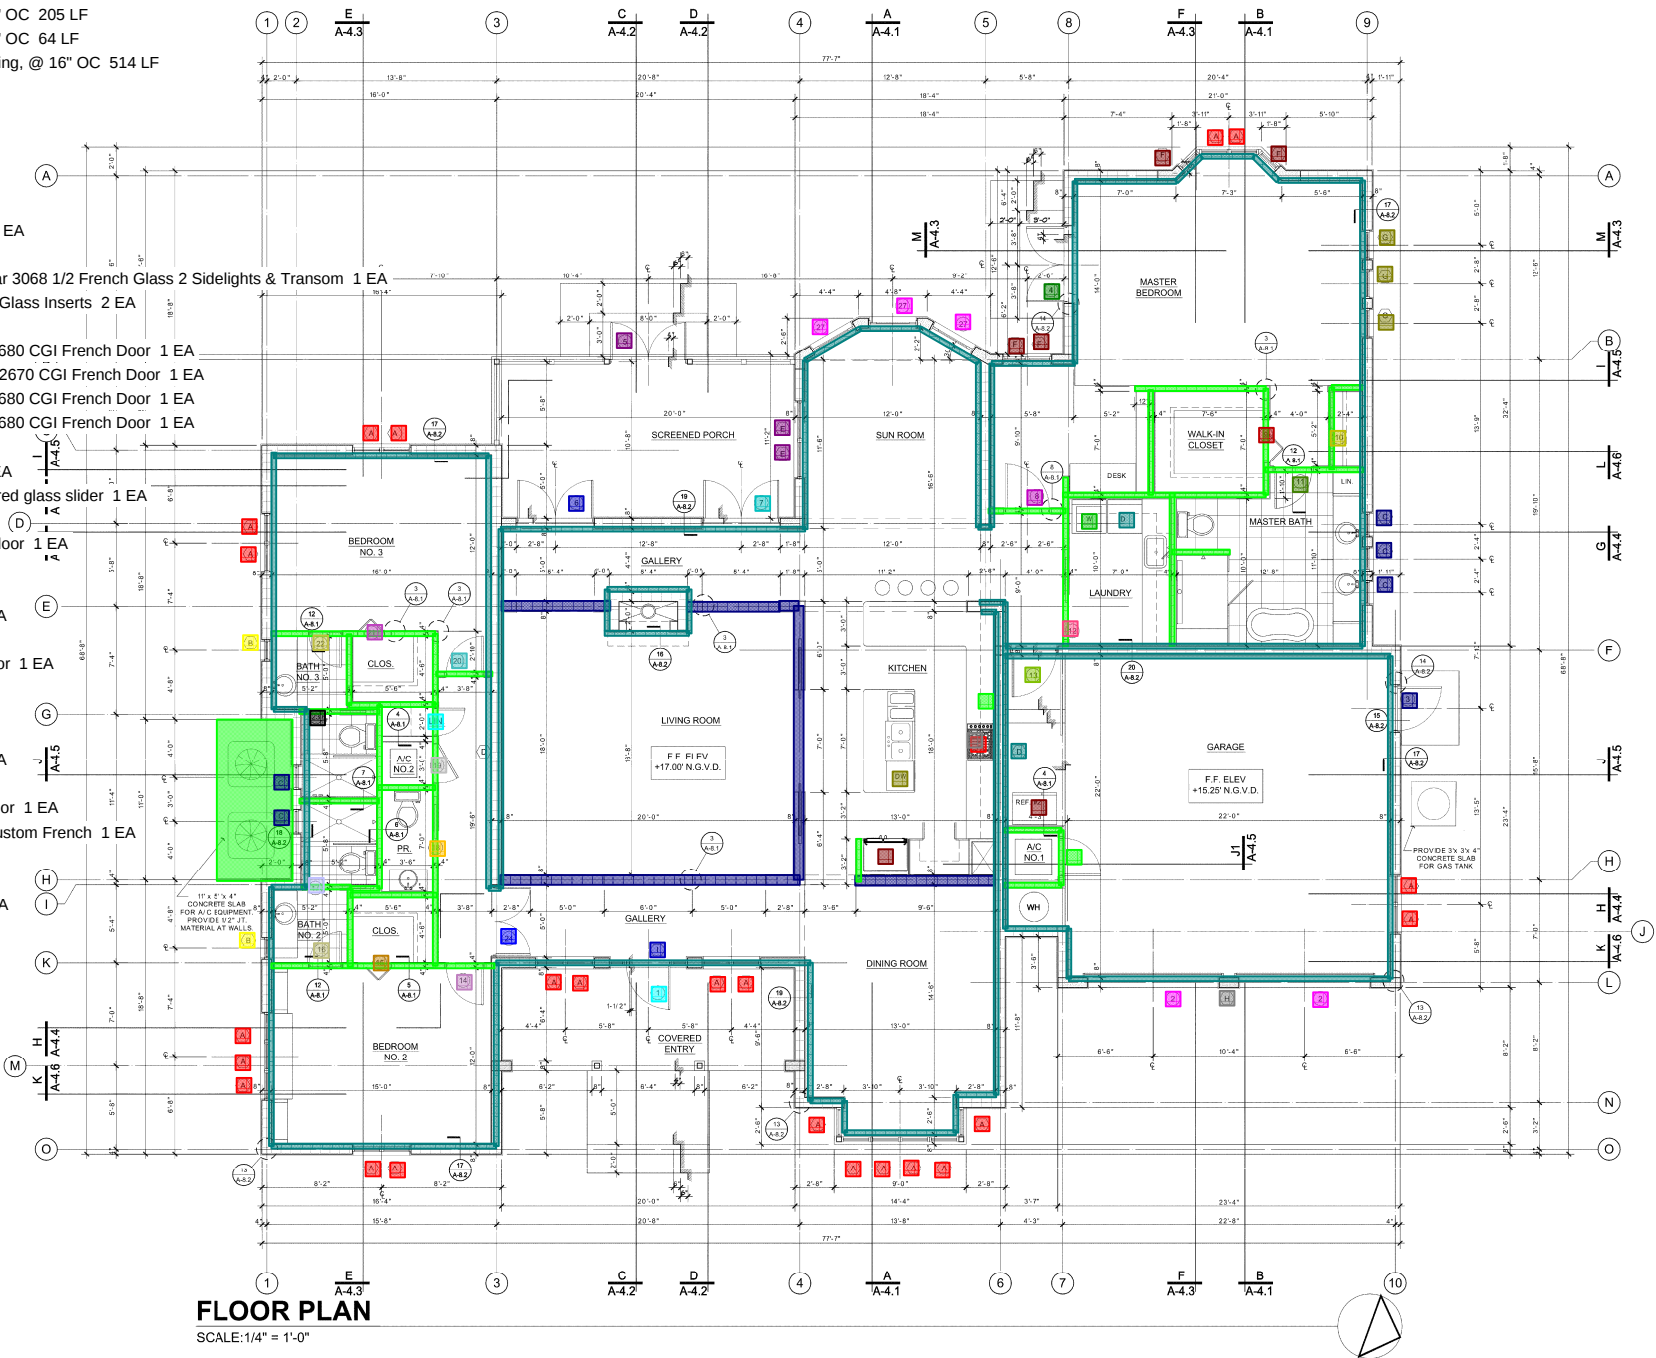

FLOOR PLAN

SCALE: 1/4" = 1'-0"

- Woncote - Smooth Veneer Plaster over 5/8" GYP on 3/4" MTL Furring 1,361 SF
- 2x6 Wood T&G Structural Sheathing over 4x8 Wood Rafters 336 SF
- 1x6 Wood T&G on Prefab Wood Trusses w/ 4x8 Decorative Wood Rafters 1,254 SF
- 5/8" GYP on 3/4" MTL Furring 562 SF

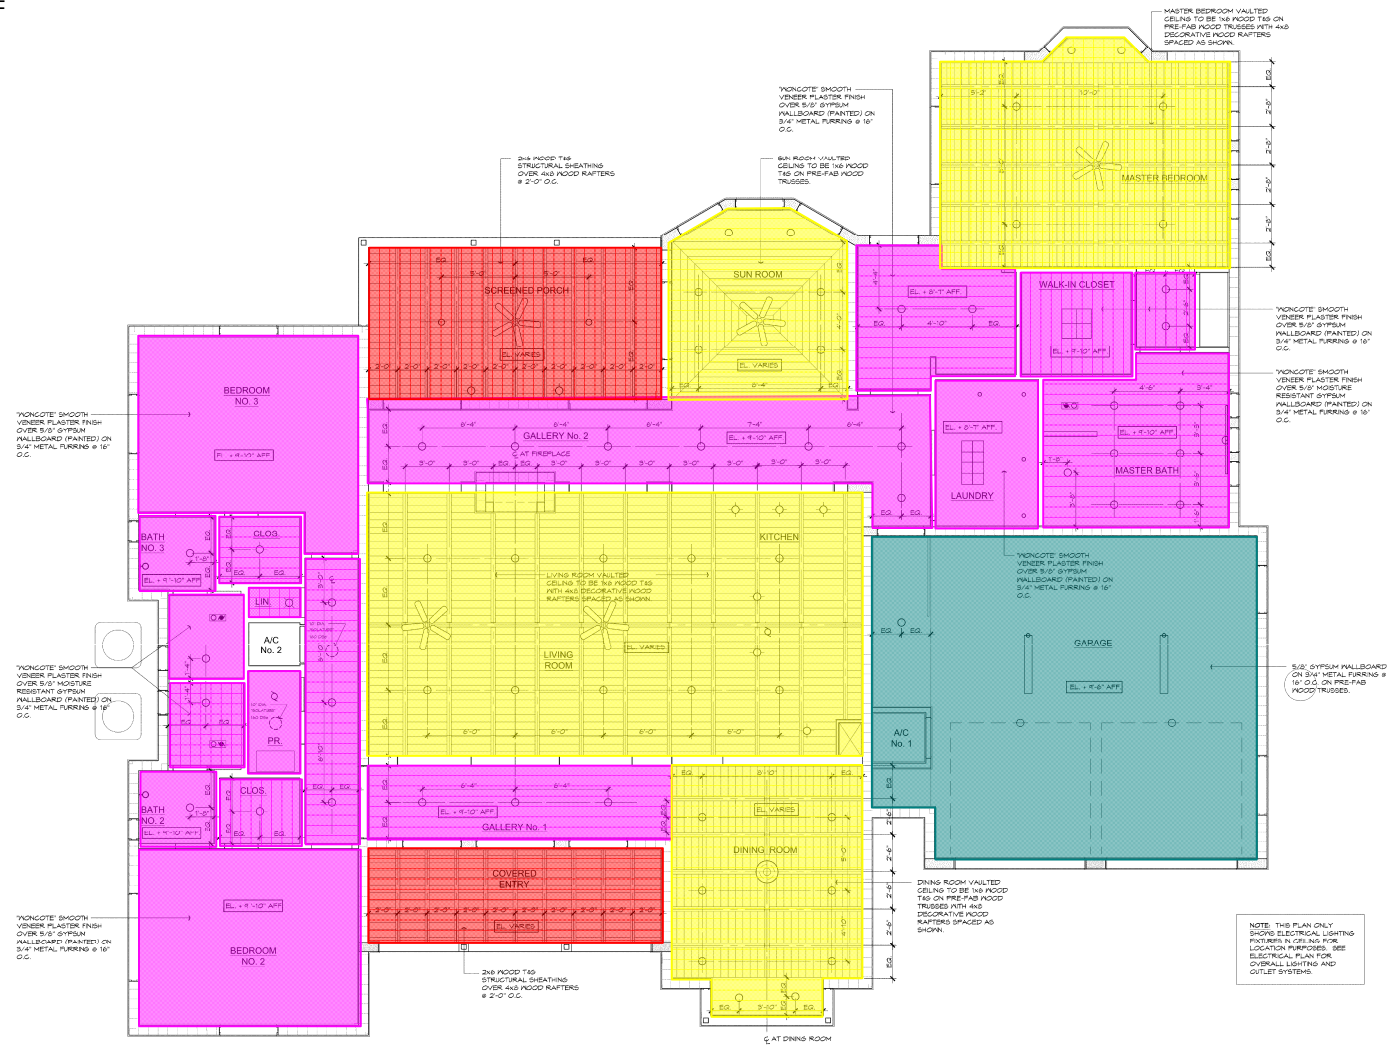

REFLECTED CEILING PLAN


SCALE: 1/4" = 1'-0"



7450 Southwest 48th Street
Miami, Florida 33155
Phone (305) 661-5392
Fax (305) 661-5832
info@architeknics.com
License # AAC000546

www.architeknics.com

NEW RESIDENCE FOR:
MARLIN EBBERT
6510 SAN VICENTE STREET
CORAL GABLES, FLORIDA 33146

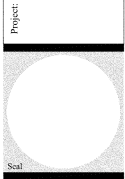

Edward C. Berensky, R.A.
License Number: AB000543

Drawing title:
**REFLECTED
CEILING PLAN**

Issue Date: Jan. 8, 2015
Revisions:

Job No.: 14107
Drawn By:
Sheet No.:

A-2.3

3/4" Smooth Stucco (3 Coat System) 2,157 SF


Random Flagged Cut Coral Rock Veneer 105 SF

Raised Stucco Band @ Base & Corner Trim 630 LF

Raised Stucco Band @ Base & Corner Trim 115 LF

Shutters 2 EA

Aluminum Screen Enclosure 162 SF

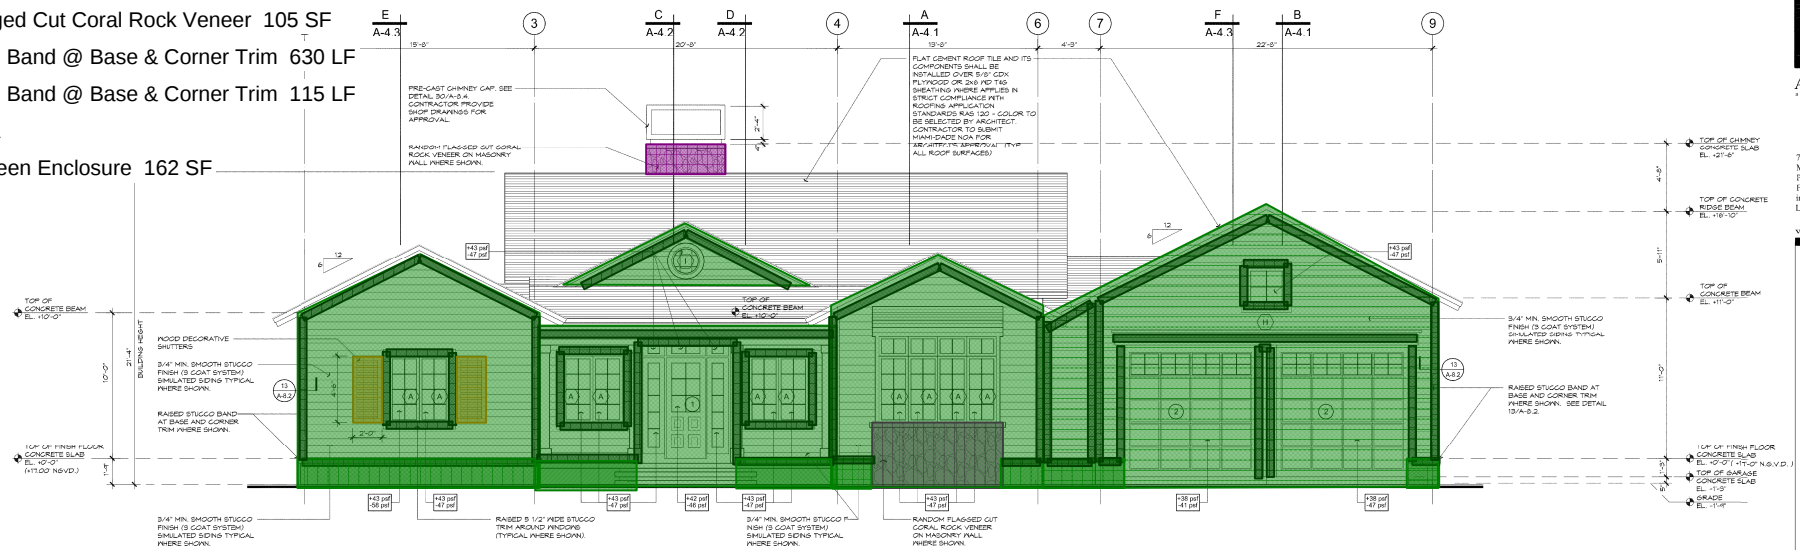

EAST ELEVATION

SCALE: 1/4" = 1'-0"



WEST ELEVATION

SCALE: 1/4" = 1'-0"



ARCHITEKNICS
ARCHITECTS & ENGINEERS

7450 Southwest 48th Street
Miami, Florida 33155
Phone: (305) 661-5392
Fax: (305) 661-5832
info@architeknics.com
License # AAC000546

www.architeknics.com

NEW RESIDENCE FOR:
MARLIN EBBERT

6810 SAN VICENTE STREET
CORAL GABLES, FLORIDA 33139

Project



Edward C. Brusinsky, R.A.
License Number: AR000543

Drawing title:

ELEVATIONS

Issue Date: Jan. 8, 2015

Revisions:

Job No.: 14107

Drawn By:

Sheet No.:

A-3.1



ARCHITEKNICS
ARCHITECTS & PLANNERS

7450 Southwest 48th Street
Miami, Florida 33155
Phone (305) 661-5392
Fax (305) 661-5832
info@architeknics.com
License # AAC000546

www.architeknics.com

NEW RESIDENCE FOR:
MARLIN EBBERT
6510 SAN VICENTE STREET
CORAL GABLES, FLORIDA 33146



Edward C. Berensky, R.A.
License Number: AB000543

Drawing title:

ELEVATIONS

Issue Date: Jan. 8, 2015

Revisions:


Job No.: 14107

Drawn By:

Sheet No.:


A-3.2

- 3/4" Smooth Stucco (3 Coat System) 1,759 SF
- Random Flagged Cut Coral Rock Veneer 37 SF
- Raised Stucco Band @ Base & Corner Trim 419 LF
- Raised Stucco Band @ Base & Corner Trim 134 LF
- Aluminum Screen Enclosure 49 SF

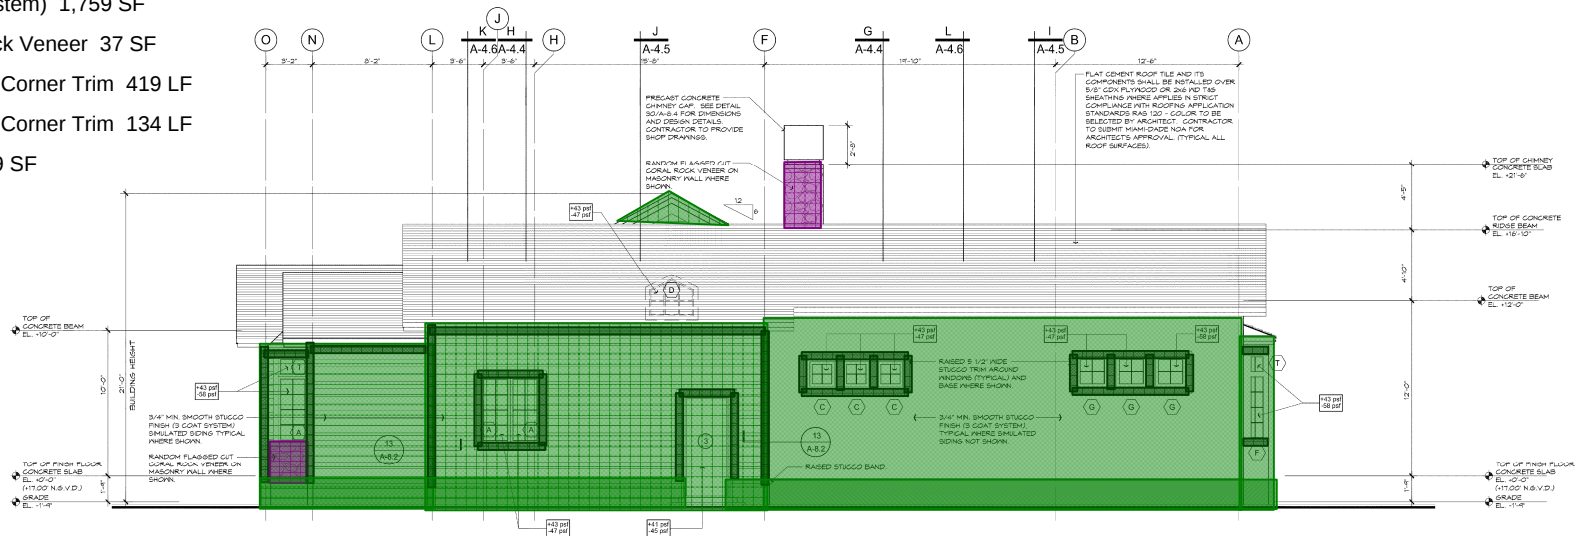




NORTH ELEVATION

SCALE: 1/4" = 1'-0"

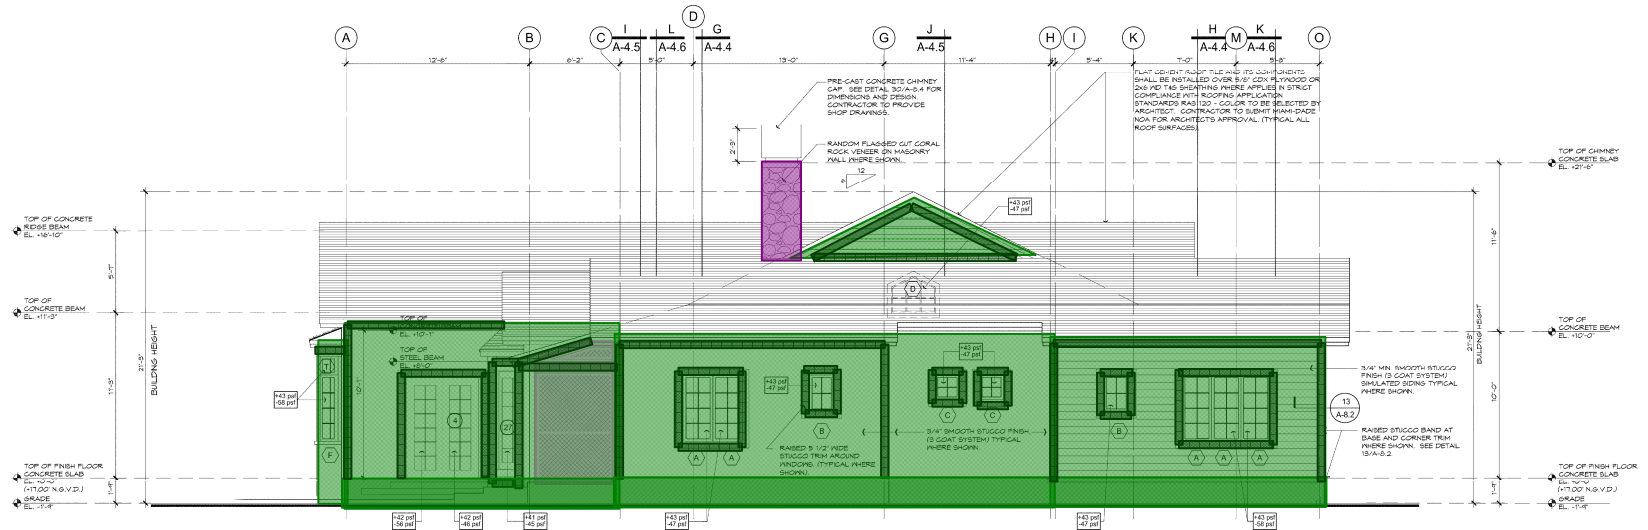

SOUTH ELEVATION

SCALE: 1/4" = 1'-0"

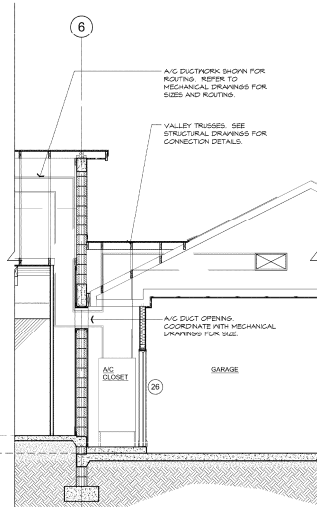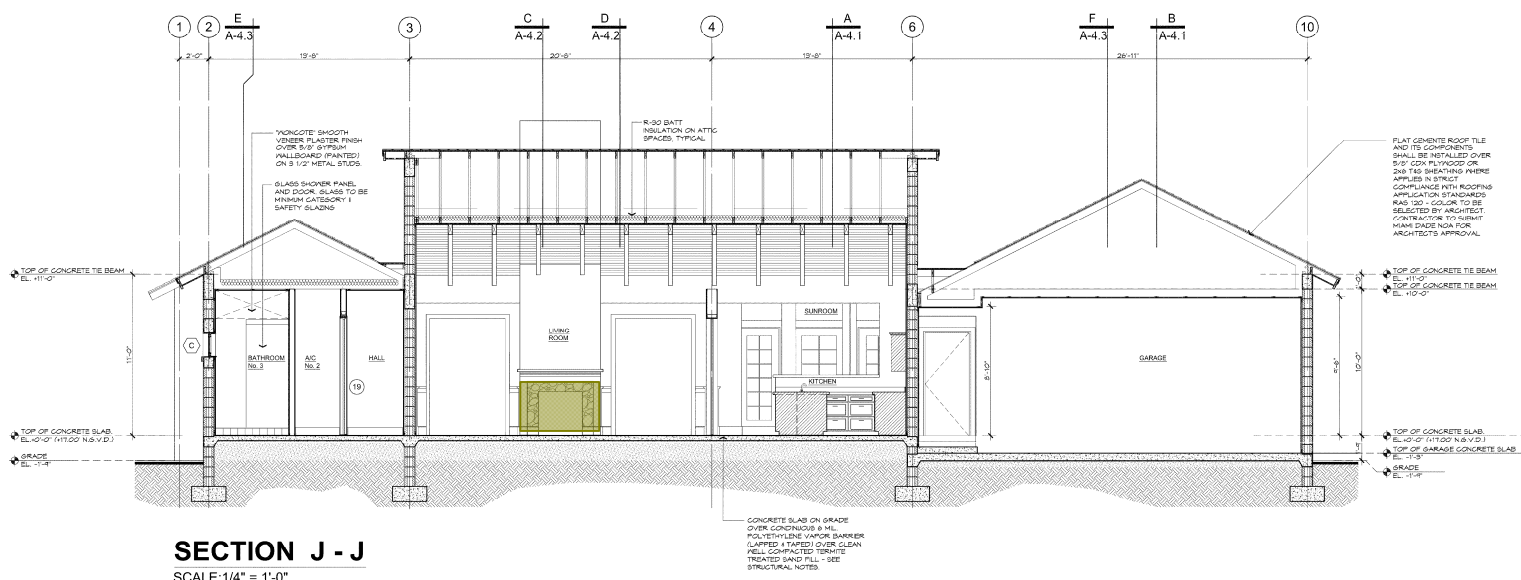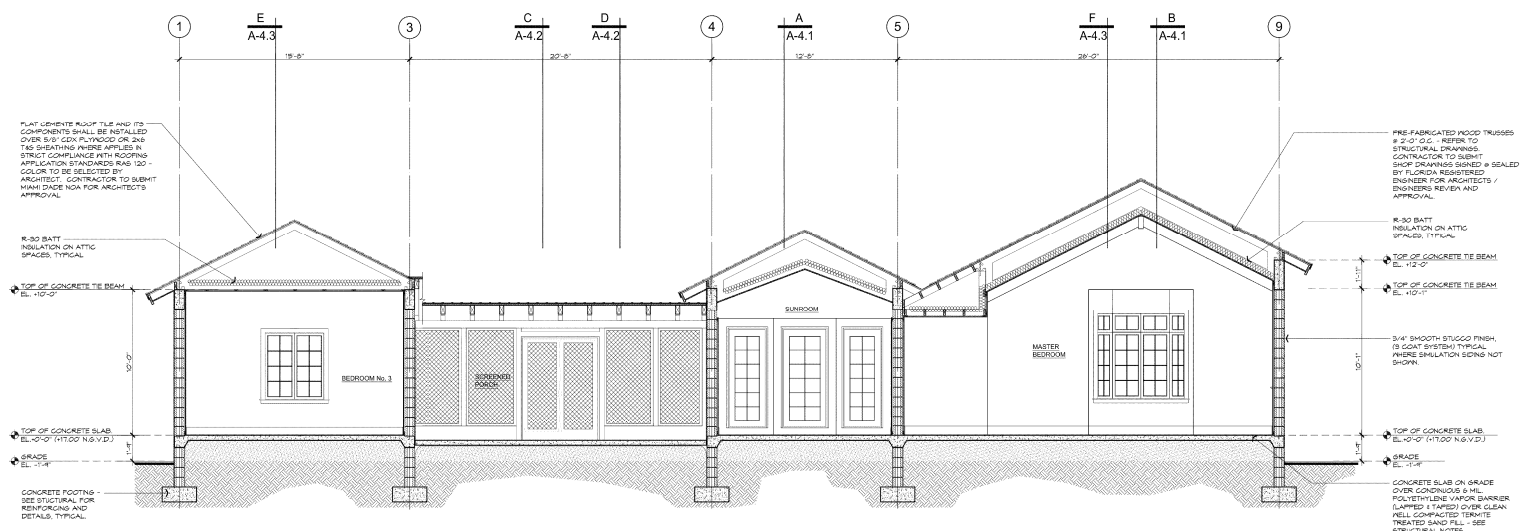



ARCHITEKTNICS
ARCHITECTS & PLANNERS

7450 Southwest 48th Street
Miami, Florida 33155
Phone (305) 661-5392
Fax (305) 661-5832
info@architektnics.com
License # AAC000346

www.architektnics.com

NEW RESIDENCE FOR:
MARLIN EBBERT
6810 SAN VICENTE STREET
CORAL GABLES, FLORIDA 33146



Edward C. Berensky, R.A.
License Number: AB0005433

Drawing title:


OVERALL
FLOOR PLAN -
NEW

Issue Date: Jan. 8, 2015
Revisions:

Job No.: 14107
Drawn By:
Sheet No.:

A-7.0

- 40" High Wood Wainscot 161 LF
- 1x8 Baseboard 581 LF
- Bathroom Vanity w/ Top 12 LF
- Kitchen Cabinets Lower 29 LF
- Kitchen Cabinets Upper 16 LF
- Desk 5 LF
- Closet Shelving 18 LF
- Laundry - Cabinets Lower 10 LF
- Pantry Shelving 7 LF
- Master Bathroom Vanity w/ Top 12 LF
- Master Walkin 24 LF
- Counter top 80 SF
- Wood 2,337 SF
- Laundry - Cabinets Wall 16 LF
- Bench/Book Case Shelves 12 LF
- Tile - Laundry 69 SF
- Tile - Bathrooms 258 SF
- Tile - Covered Entry 200 SF
- Tile - Screened Porch 337 SF
- Desk Shelving 7 LF
- Tile - Walls 251 SF
- Shower Enclosure 3 EA

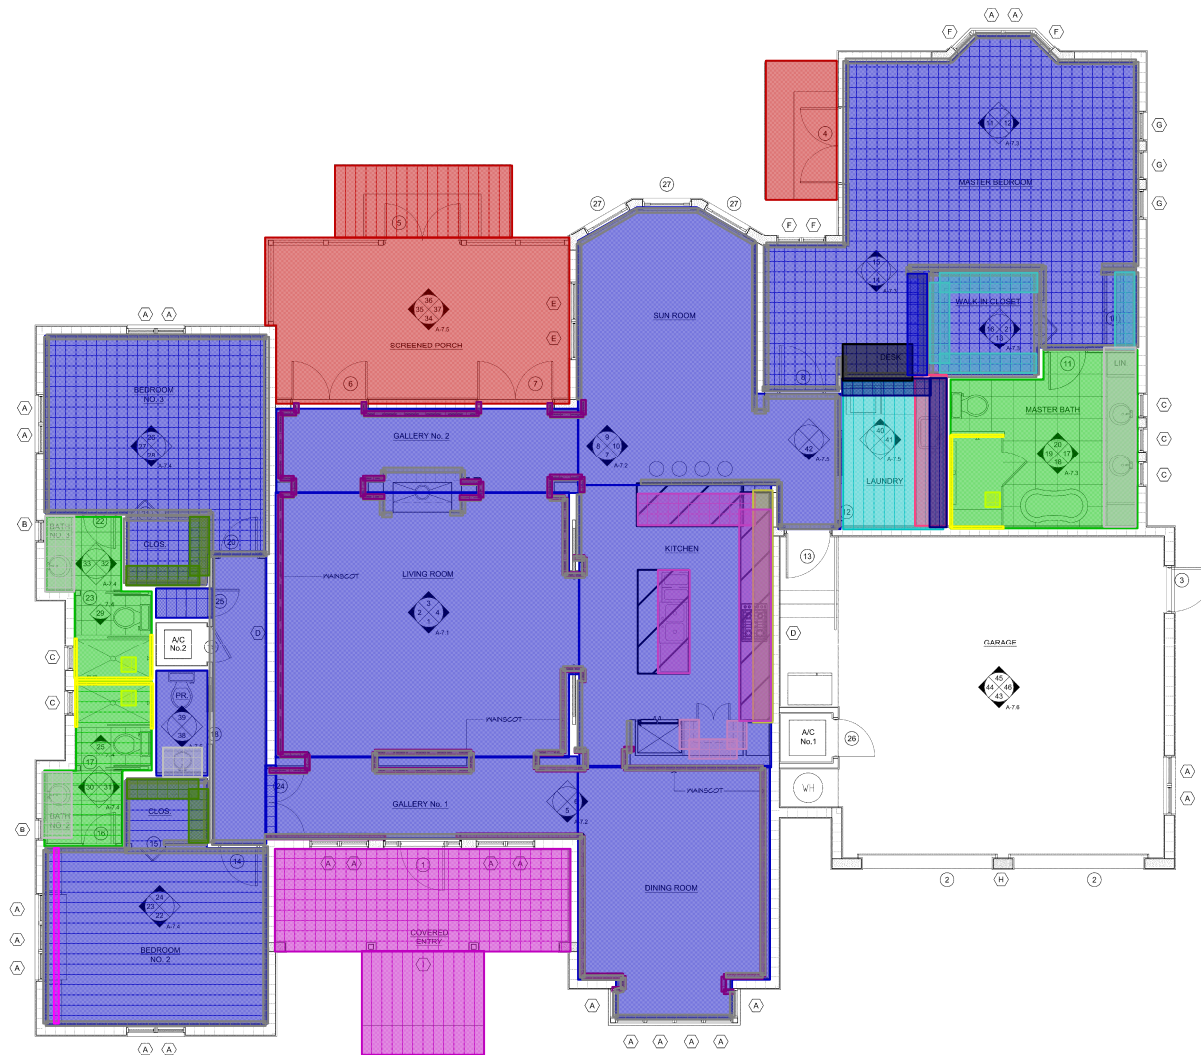


FLOOR PLAN FOR INTERIORS REFERENCE

SCALE: 1/4" = 1'-0"



- WF-1 - 18"x14" 423 LF
- WF-2 - 24"x14" 120 LF
- WF-3 - 30"x14" 11 LF
- F1 - 3.5'x3.5'x14" 1 EA
- F2 - 4.67'x8.0'x16" 1 EA
- Block Walls Below Grade 550 LF
- Floor slab system - 4" Slab on Grade 3,251 SF
- Floor slab system - 6" Slab on Grade 817 SF
- CMU Walls 420 LF
- Columns 22 EA
- Steel Columns 5 EA

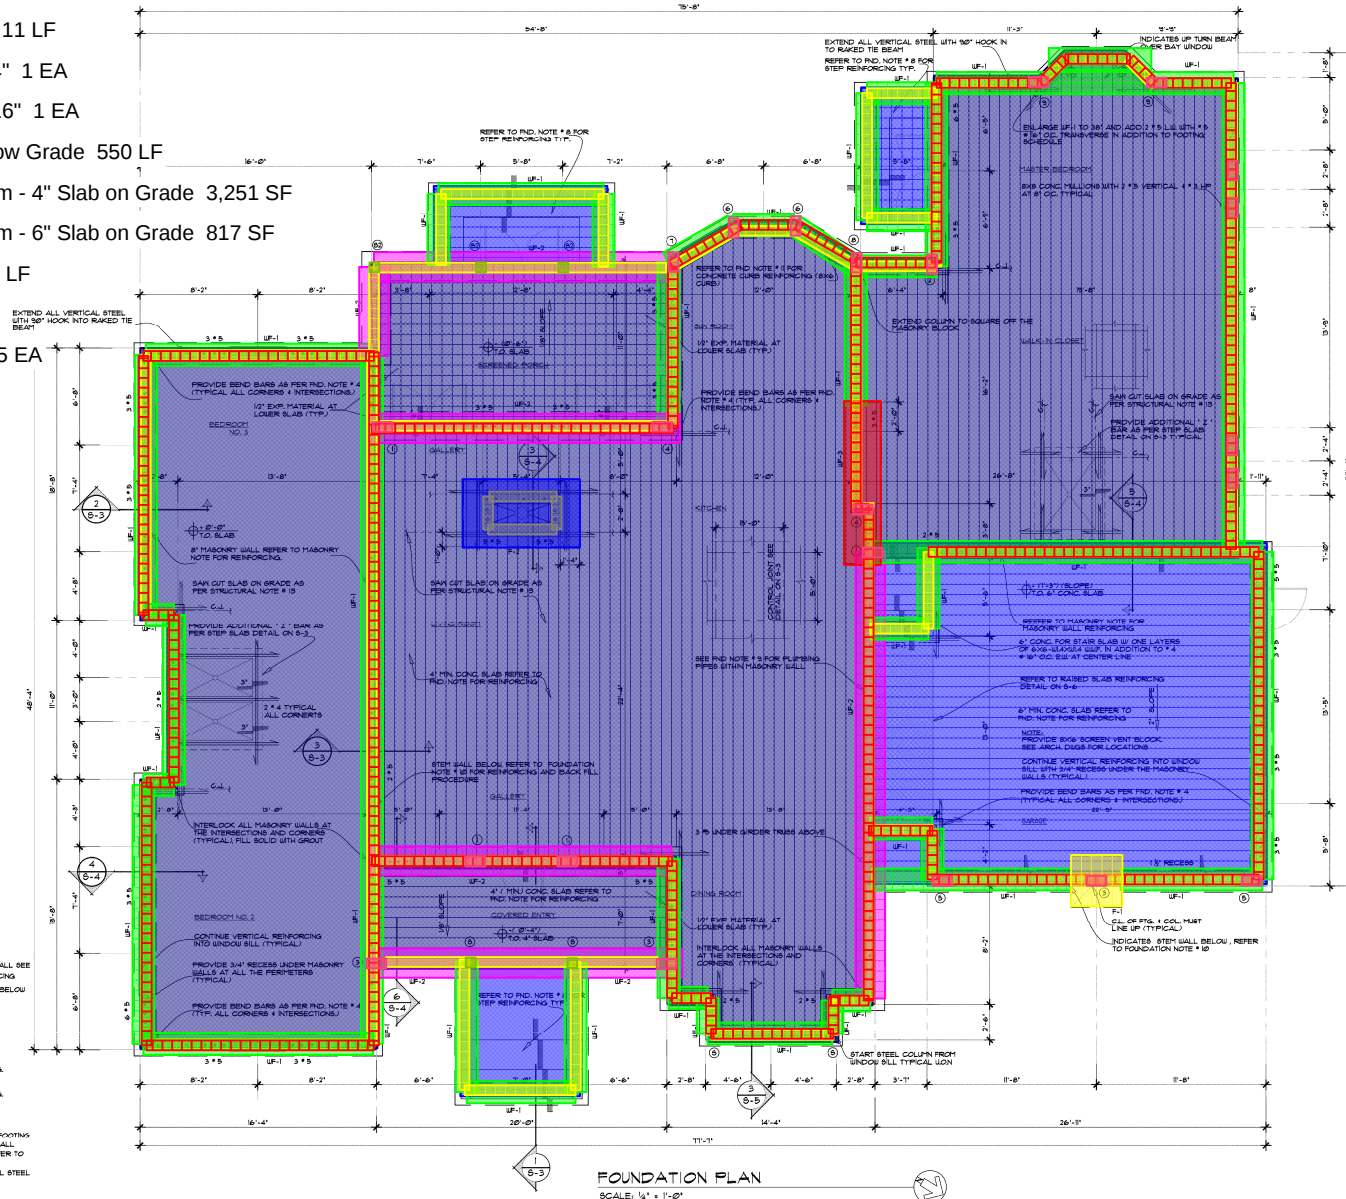

MASONRY REINFORCING:
ALL CONCRETE BLOCK TO BE BURNED WITH MIN. COMPRESSIVE STRENGTH OF 1500 PSI. PROVIDE 1/2" HOOK IN C/L OF MASONRY AT MAX. SPACING OF 30" O.C. (1/2" HOOK FILL CELLS WITH GROUT). GROUT FILL CELLS BEFORE PLACING GROUT. RE-CONSOLIDATE EACH LIFT AT MAX. OF 8" LIFT WITH LOW VELOCITY 3/4" MECHANICAL VIBRATOR. REFER TO TYPICAL FILL CELL MASONRY DETAIL. PLACE ONE BAR AT EACH SIDE OF ALL MASONRY OPENINGS. PLACE ADDITIONAL BAR FOR EVERY INCREMENT EXCEEDING INDICATED SPACING. REFER TO TYPICAL CORNER DETAIL FOR ADDITIONAL REINFORCING. PROVIDE HORIZONTAL REINFORCING 5 GAGE LADDER TYPE EVERY OTHER COURSE THROUGH-OUT ALL MASONRY WALLS. (DO NOT USE FIBERGLASS REINFORCING FOR MASONRY WALLS). ALL MASONRY WALLS MUST BE GROUTED PRIOR TO FORMING ANY BEAMS (FIRST AND ROOF BEAMS).

FOUNDATION NOTES:
1. SLAB TO BE 4" THICK W/ 6X6-16@4'S ELEV. (1/2" HOOK) SUPPORTED ON SLAB BOOSTER 3" 2" O.C. ON 6" HIL VARIOUS BARRIER OR HIL OF MODIFIED PROCTOR IN ACCORDANCE WITH ASTM D 1587.
2. TOP OF SLAB 8" 8" O.C. LON.
3. TOP OF WALL 4" COL. FOOTING 4" 4" O.C. BELOW PROPOSED GRADE.
4. CENTER LINE OF FOOTING AND WALLS. COLUMN MUST LINE UP WITH LON.
5. OVER LAP ALL FOOTING STEEL AT ALL CORNERS 12" APART (TYPICAL).
6. DISCONTINUOUS EDGES OF ALL SLAB SHALL HAVE 8X10 TIE WITH 2" 2" O.C. (1/2" HOOK).
7. HOUSE KEEPING PAD FOR A.C. SHALL BE 8" 8" TYP. TWO LAYER OF 1/2" 1/2" 1/2" O.C. TIE.
8. PROVIDE 2" 4" 4" 8" LONG AT MID DEPTH OF CONC. SLAB AT ALL REINFORCED CORNERS 12" FROM CORNER 12" APART (TYPICAL).
9. USE 6" 6" SLAB FOR ALL CONC. STEPS WITH 4" 4" 6" O.C. N. IN ADDITION TO FILL 1/2" 1/2" O.C. TIE.
10. ALL HORIZONTAL REINFORCING WITHIN THE MASONRY WALLS MUST BE FORMED SOLID WITH CONCRETE WITH 8" 8" O.C. HORIZONTAL (TYP. 5" 5" 8" O.C.).
11. ALL MASONRY WALLS BELOW FIRST FLOOR (8" 8" WALLS) MUST BE FILLED WITH GROUT PRIOR TO BACK FILL AND COMPACTION.
12. DOUBLE OUT 4" 4" 8" O.C. W/ 2" 2" 2" O.C. FOR ALL CONC. CURBS (ALL) IN ADDITION TO MASONRY REINFORCING REFER TO ARCH. DWG'S FOR LOCATION.

NOTE:
ALL DIMENSIONS ELEVATIONS & PRIVACY WALLS LOCATION MUST BE CHECKED & VERIFY WITH ARCHITECTURAL DRAWINGS PRIOR TO CONSTRUCTION.



3500 Southwest 48th Street
Miami, Florida 33155
Phone (305) 661-5392
Fax (305) 661-5833
info@architeknics.com
License # AAC000546

www.architeknics.com

MARLIN EBBERT
NEW RESIDENCE FOR
6510 SAN VICENTE STREET
CORAL GABLES, FLORIDA 33146



Edward C. Broussard, R.A.
License Number: AB000457

VAZIRI & ASSOCIATES, INC.
STRUCTURAL ENGINEERS
10000 W. BIRCH AVE., SUITE 100
DADE CITY, FL 34608
TEL: (813) 841-1111
FAX: (813) 841-1112
www.vaziri.com
JULY 2014

Drawing title:

FOUNDATION PLAN

Issue Date: 10-24-2014

Revisions:

Job No.: 14107

Drawn By:

Sheet No.:

S-1

COORDINATION NOTE
GENERAL CONTRACTOR TO COORDINATE ALL VERTICAL AND HORIZONTAL DIMENSIONS AND ALL MATERIALS AND FINISHES WITH ARCHITECT DRAWINGS (DON'T PROCEED WITH WORK UNLESS ALL DIMENSIONS & ELEVATIONS HAVE BEEN CHECKED AND VERIFIED WITH ARCHITECTURAL DRAWINGS).



COORDINATION NOTE
GENERAL CONTRACTOR TO COORDINATE ALL VERTICAL AND HORIZONTAL DIMENSIONS AND ALL MATERIALS AND FINISHES WITH ARCHITECT DRAWINGS (DON'T PROCEED WITH WORK UNLESS ALL DIMENSIONS & ELEVATIONS HAVE BEEN CHECKED AND VERIFIED WITH ARCHITECTURAL DRAWINGS)

- Duplex Receptacle 15A 110V 63 EA
- Wall mounted fixture 5 EA
- Special Receptacle Outlet 4 EA
- Ceiling Lighting Fixture 6 EA
- Exterior Wall Bracket Light - WP 9 EA
- Exhaust Fan 4 EA
- Weatherproof Recessed Can 5 EA
- Wall Switch 15A, 125V 73 EA
- Ceiling fan 7 EA

- Disconnecting Switch 5 EA
- TV Outlet 4 EA
- Tree Way Toggle Switch 9 EA
- Track Lighting 1 EA
- Manual Transfer Switch 2 EA
- Exterior Floodlights 6 EA
- Low voltage hi-hat fixture 63 EA
- Duplex Receptacle 15A 110V GFI 19 EA
- Duplex Receptacle 15A 110V GFI WP 13 EA
- AHU Connections 3 EA
- Ceiling Lighting Fixture 2 EA
- Ceiling Lighting Fixture 2 EA
- Ceiling Lighting Fixture 1 EA
- Garage Opener 2 EA

- MULTIPLE DETECTORS MUST BE TANDUM CONNECTED, SO THAT WHEN ONE SOUNDS, THEY ALL SOUND.
- SMOKE DETECTORS SHALL BE MOUNTED 3'-0" MINIMUM FROM SUPPLY GRILLES, RETURN GRILLES AND TRANSFER GRILLES AS WELL AS 3'-0" FROM THE KITCHEN AND BATHROOM DOORS.
- A SMOKE DETECTOR LOCATED WITHIN 20 FEET OF A COOKING APPLIANCE SHALL BE OF THE PHOTOELECTRIC TYPE OR IONIZATION TYPE WITH AN ALARM SILENCING MEANS.
- SMOKE DETECTORS SHALL HAVE BATTERY BACK UP.

RECEPTACLES AND OUTLETS TEST NOTES

- THE ELECTRICAL CONTRACTOR SHALL TEST ALL RECEPTACLES AND LIGHTING FIXTURES OUTLETS FOR THE FOLLOWING:
 - OPEN GROUND.
 - OPEN NEUTRAL.
 - OPEN HOT.
 - HOT/GROUND REVERSE.
 - HOT/NEUTRAL REVERSE.
- SHOULD THE ELECTRICAL CONTRACTOR FIND, AFTER TESTING FOR ANY OF THE ABOVE CONDITIONS, THE DEFICIENCY SHALL BE CORRECTED TO CONFORM TO THE REQUIREMENTS OF THE N.E.C.

TAMPER RESISTANT RECEPTACLE NOTE

- ALL EXISTING 15 AMP AN 20 AMP AS INDICATED WITH A "T" ADJACENT TO THE SYMBOL SHALL BE TAMPER RESISTANT AS PER N.E.C. 210.52(A) AND COMPLY WITH N.E.C. 406.11.

RECEPTACLE & TOGGLE SWITCH NOTES

- ALL RECEPTACLES AND COVER PLATES SHALL BE AS SELECTED BY THE OWNER MULTI-GANG SWITCH PLATES ARE TO BE USED WHEN SWITCHES ARE ADJACENT.
- HEIGHT OF SWITCHES TO BE COORDINATED BY THE OWNER ON SITE. COORDINATE DIMMING SWITCHES WITH THE ARCHITECT.

V.P. FIXTURE NOTES.


- VAPOR PROOF FIXTURES SHALL COMPLY WITH N.E.C. 410-4 (g) AND SHALL BE MARKED SUITABLE FOR DAMP LOCATIONS.

LUMINAIRES IN CLOSETS

- LUMINAIRES IN CLOSETS SHALL COMPLY WITH N.E.C. 410.8.

LIGHTING FIXTURE LAMP NOTES

- A MINIMUM OF 50% OF THE LAMPS IN PERMANENTLY INSTALLED LIGHTING FIXTURES SHALL BE HIGH-EFFICIENCY LAMPS IN ACCORDANCE WITH THE FBC ENERGY CONSERVATION 404.1 LIGHTING EQUIPMENT.
- HIGH-EFFICIENCY LAMPS ARE AS FOLLOWS:
 - COMPACT FLOURESCENT
 - T-8 LAMPS OR SMALLER
 - 60 LUMENS PER WATT FOR LAMPS OVER 40 WATTS
 - 50 LUMENS PER WATT FOR LAMPS OVER 15 WATTS TO 40 W
 - 40 LUMENS PER WATT FOR LAMPS LESS THAN 15 WATTS

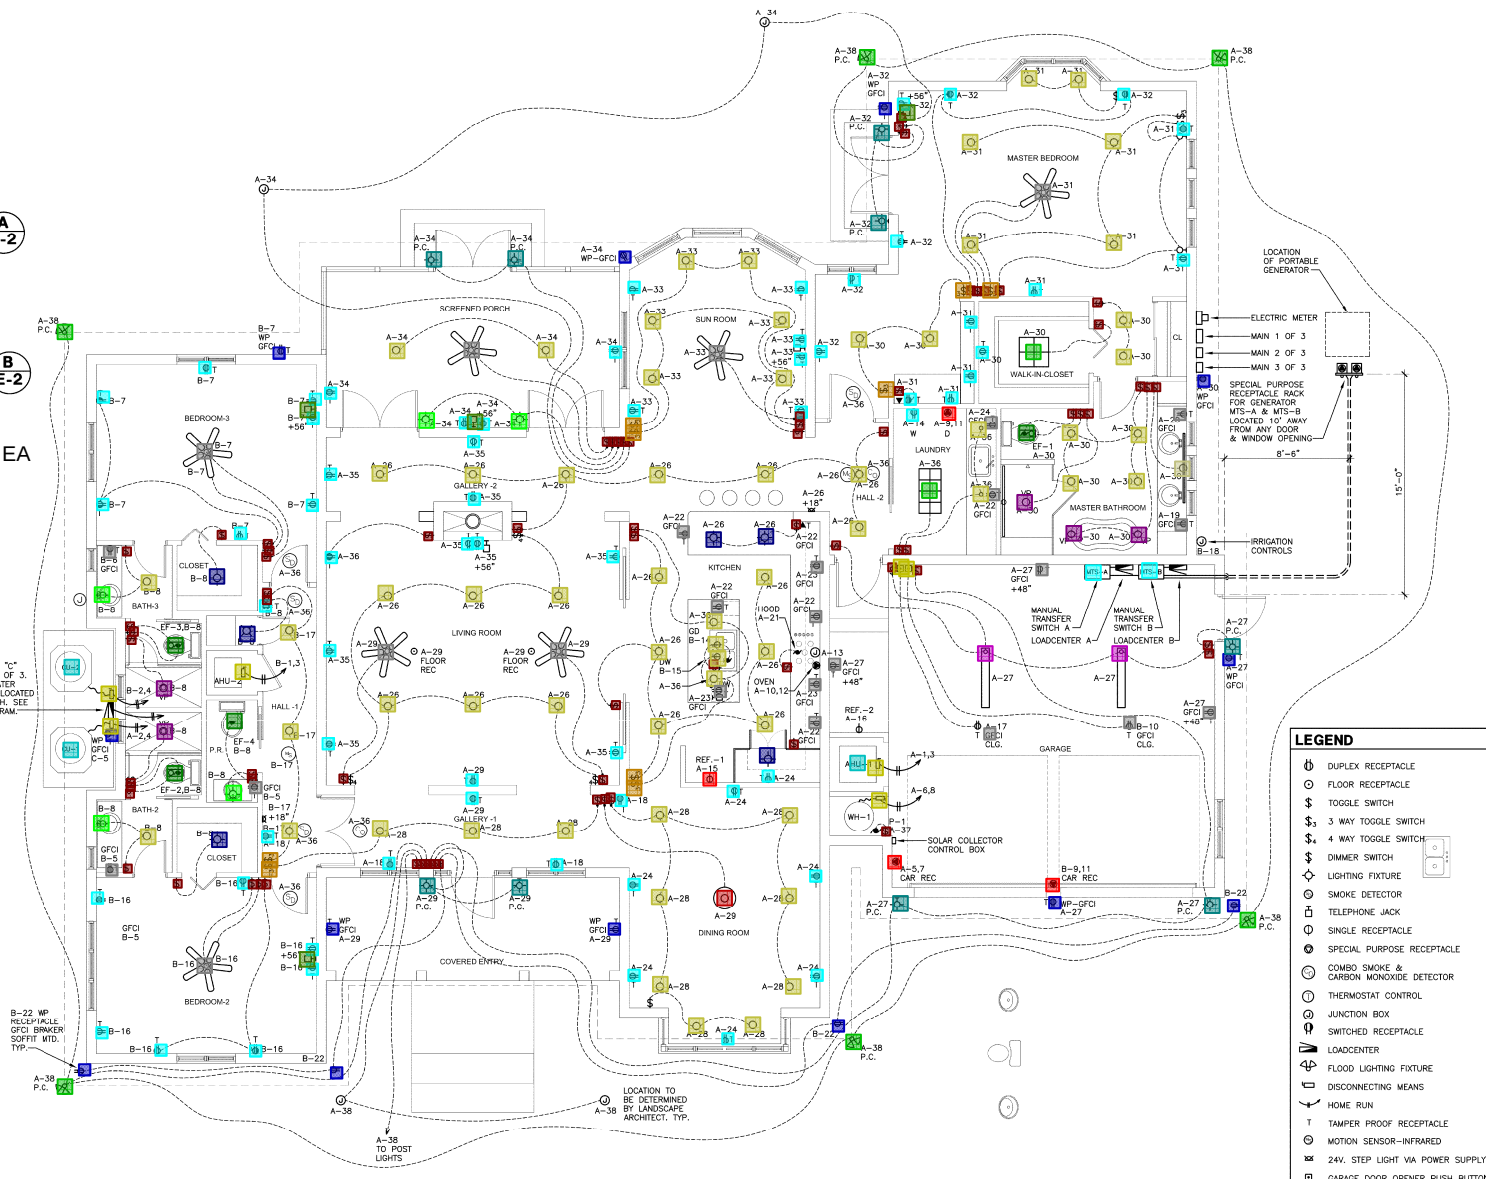

POWER & LIGHTING FLOOR PLAN

SCALE: 1/8" = 1'-0"



EBBERT RESIDENCE
BFA-JOB 14032



BHAMANN, FORD, & ASSOCIATES INC.
CONSULTING ENGINEERS & PLUMBERS
4800 N.W. 14 COURT, MIAMI, FLORIDA 33196
(305) 486-1000, 486-8800, FAX 1000 487-9000

THOMAS H. MAXWELL JR., P.E.
FLORIDA P.E. LICENSE NO. 10100




ARCHITEKNIKS
ARCHITECTS & PLANNERS

7450 Southwest 48th Street
Miami, Florida 33155
Phone (305) 661-5392
Fax (305) 661-5832
info@architektniks.com
License # AAC000546

www.architektniks.com

NEW RESIDENCE FOR:
MARLIN EBBERT
6605 SAN VICENTE STREET
CORAL GABLES, FLORIDA 33146

Project:

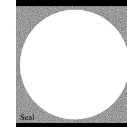

Edward C. Berensky, RA
License Number: AR000433

Drawing title:

**POWER &
LIGHTING
FLOOR PLAN**

Issue Date: 10-DEC-14

Revisions:

Job No.: 14107

Drawn By:

Sheet No.:

E-2

OF 3



ARCHITEKTNICS
ARCHITECTS & ENGINEERS

7450 Southwest 48th Street
Miami, Florida 33155
Phone (305) 661-5392
Fax (305) 661-5832
info@architektnics.com
License # AAC000546

www.architektnics.com

NEW RESIDENCE FOR:
MARLIN EBBERT
6919 SAN VICENTE STREET
CORAL GABLES, FLORIDA 33146

Project:

Scal:

Edward C. Beroukany, RA
Florida Number: ARCHITECT

Drawing title:
**MECHANICAL
FLOOR PLAN**

Issue Date: 10-DEC-14
Revisions:

NO.	REVISION	DATE

Job No.: 14107
Drawn By: MF/FTB
Sheet No.:
M-1
OF 3

BHAMANI, FORD & ASSOCIATES INC.
CONSULTING ENGINEERS & PLANNERS
4909 N.W. 74 COURT, MIAMI, FLORIDA 33185
1000 800-984-960-8900, FAX 1000-867-8088

EBBERT RESIDENCE
BFA-JOB 14032

THOMAS H. MAXWELL, JR., P.E.
FLORIDA P.E. LICENSE NO. 10100

- Rigid Duct Work 604 SF
- 6" Diameter Flexi-Duct 61 LF
- 8" Diameter Flexi-Duct 35 LF
- 6" Diameter Mtl-Duct 39 LF
- 10" Diameter Flexi-Duct 10 LF
- 4" Diameter Flexi-Duct 37 LF
- EF-1 Greenheck No. SP-A50 4 EA
- Diffusers/Grills 19 EA
- 4' Linear Diffuser 5 EA
- Rings 53 EA
- Boxes 30 EA
- AHU-1 - RHEEM RHLL-HM3821 1 EA
- AHU-2 - RHEEM RHLLHM2417 1 EA
- CU-1 - RHEEM 14AJN036A01 1 EA
- CU-2 - RHEEM 14AJMO19A01 1 EA
- 2' Linear Diffuser 7 EA
- KF-1 400 CFM 1 EA

LEGEND

NEW SUPPLY AND RETURN AIR

EXHAUST AIR THROUGH FAN

CONDENSATE LINES

CONDENSATE DUCT UP


CIRCULAR DUCT UP

DIRECTION OF FLOW

EXHAUST OR RETURN AIR FLOW

CONDENSING A/C UNIT TO BE MIN. 10 FT. FROM ANY ADJ. PROPERTY LINES-TYPICAL

NOTE: G.C. TO COORDINATE W/ MECH. CONTRACTOR TO VERIFY MIN. 6" SERVICE CLEARANCE ON SIDES AND 4" AT THE BACK AND FRONT OF THE ACTUAL AHU HOUSING FBC 2010-M603.1.3

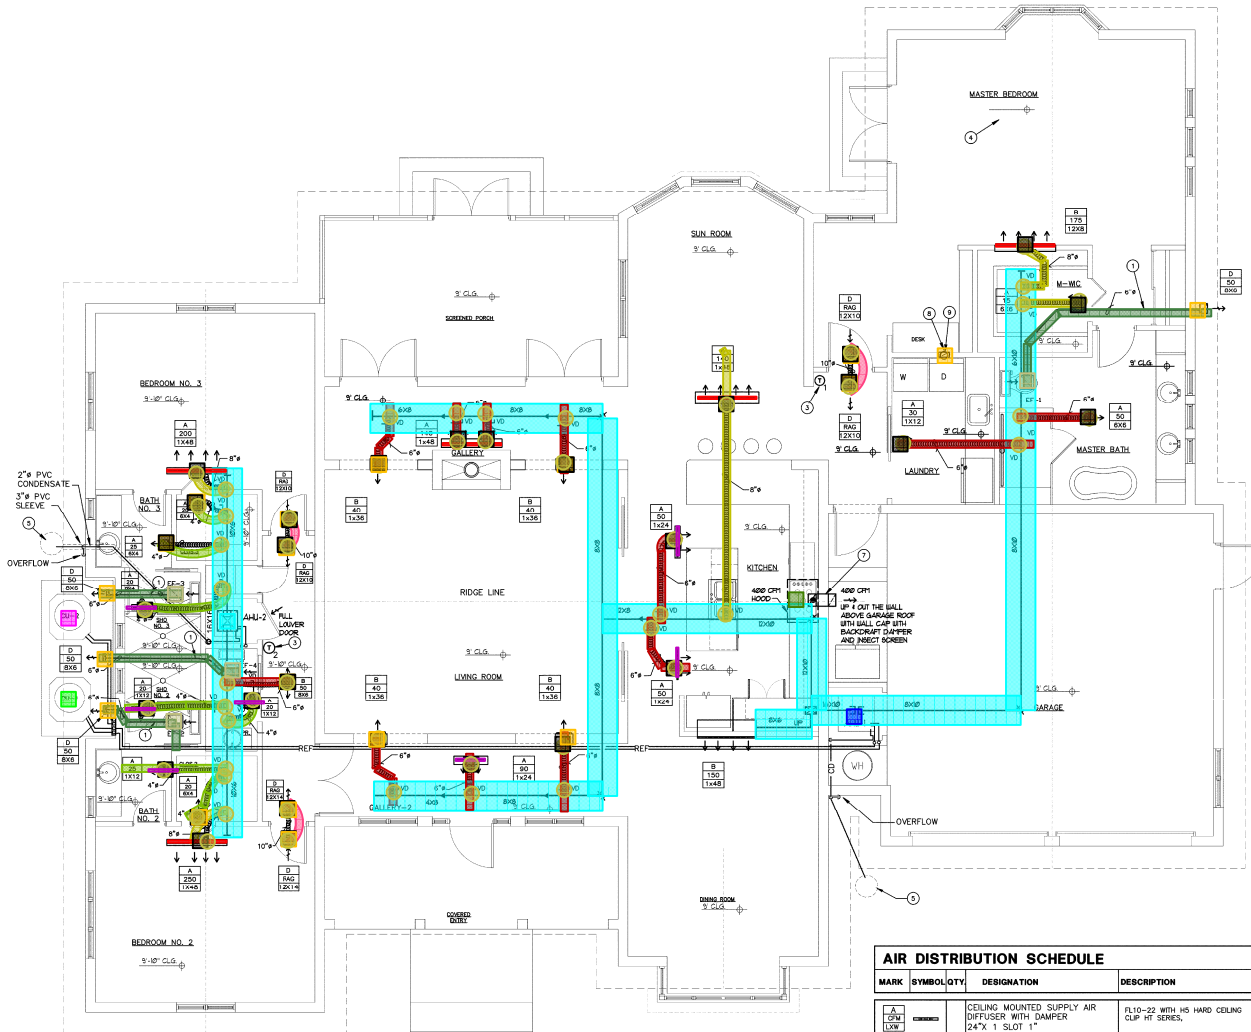


MECHANICAL FLOOR PLAN
SCALE: 1/4" = 1'-0"

AIR DISTRIBUTION SCHEDULE						
MARK	SYMBOL	QTY	DESIGNATION	DESCRIPTION	MATERIAL	FINISH
A	CLIP	1	CEILING MOUNTED SUPPLY AIR DIFFUSER WITH DAMPER 24" X 1 SLOT 1"	FL10-22 WITH H5 HARD CEILING CLIP HT SERIES,	ALUMINUM	WHITE
B	CLIP	1	WALL MOUNTED NEW SUPPLY AIR DIFFUSER WITH DAMPER 24" X 1 SLOTS 1"	FL10-22 WITH H5 HARD CEILING CLIP HT SERIES,	ALUMINUM	WHITE
C	CLIP	1	641 ALUMINUM WALL CAP WITH BACK DRAFT DAMPER AND INSECT SCREEN		ALUMINUM	WHITE
D	CLIP	1	CEILING MOUNTED RETURN AIR DIFFUSER	350FL ALUMINUM	ALUMINUM	WHITE
E	CLIP	1	CEILING MOUNTED EXHAUST FAN AIR GRILL	PROVIDED WITH EXHAUST FAN KITS	POLYMER	WHITE
VD	CLIP	1	VOLUME DAMPER	SEE DETAIL D/M-3		
NT	CLIP	1	NEW THERMOSTAT	HONEYWELL VISONPRO 8000 TOUCHSCREEN THERMOSTAT WITH HUMIDITY CONTROL		HONEYWELL

- Septic Tank - 1050 GAL TANK 1 EA
- Utility Service Water distribution piping 68 LF
- Utility Service Water Meter and Shut off Valve 1 EA
- Utility Service Trenching 79 LF
- Utility Service Sanitary Trenching 84 LF
- Utility Service Tank Excavation 12 LF

3. DRAINFIELD IS SIZED UPON 3 MIN./INCH PERCOLATION RATE. SHOULD OTHER CONDITIONS BE ENCOUNTERED, NOTIFY THE ARCHITECT PRIOR TO COMMENCEMENT OF WORK.
4. DRAIN FIELD SHALL BE 667 SQ.FT. MINIMUM. UNOBSTRUCTED AREA 1000 SQ.FT. (INCLUDES DRAIN FIELD AREA)

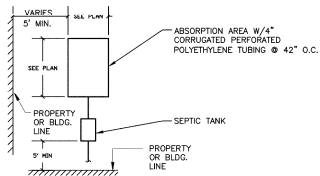

5. 4" POLYETHYLENE TUBING SHALL BE PLACED ON A 24" BED OF CLASS TWO SILICA SAND

NOTE

PROVIDE SITE EVALUATION CRITERIA

SEPTIC TANK AND DRAINFIELD NOTES

- THE INFLUENT INVERT SHALL BE 1" MIN. TO 3" MAX. ABOVE EFFLUENT INVERT. IF OVER 1", COORDINATE THE FLOOR ELEVATION OF THE RESIDENCE TO INCREASE.
- THE SEPTIC TANK SHALL BE PREFABRICATED. CONCRETE SHALL BE 3000 PSI @28 DAYS.
- THE DRAINFIELD PIPING SHALL BE 4" POLYETHYLENE CORRUGATED TUBING.
- PRIOR TO THE INSTALLATION OF THE SEPTIC TANK, THE DRAINFIELD AND FINISH FLOOR OF THE RESIDENCE, THE EXACT PITCH OF THE SANITARY PIPING SHALL BE ESTABLISHED TO MATCH THE REQUIRED ELEVATION OF THE MOST DISTANT POINT OF THE DRAINFIELD.

SEPTIC TANK ABANDONMENT NOTES

- THE EXISTING SEPTIC TANK SHALL BE ABANDONED
- A SEPTIC TANK CONTRACTOR SHALL OBTAIN AN "ABANDONED TANK PERMIT"
- THE EXISTING TANK SHALL BE PUMPED OUT.
- THE EXISTING TANK SHALL HAVE THE BOTTOM BROKEN OUT IN ACCORDANCE WITH D.E.R.M.
- THE INLET PIPE SHALL BE DISCONNECTED FROM THE TANK.
- THE TANK SHALL BE FILLED WITH SAND AND WATERED DOWN FOR COMPACTION.
- THE SEPTIC TANK CONTRACTOR SHALL CALL FOR AN INSPECTOR BY D.E.R.M.

ZONING INFORMATION


PROPERTY ADDRESS: 6510 SAN VICENTE STREET, CORAL GABLES, FL 33146

LOT SIZE 105.06' X 105.06' = 11,037 SF

LOT COVERAGE


MAXIMUM ALLOWED: 35% = 3,862 SF
PROVIDED: 3,856 SF
UNDER A/C 2,914 SF
PATIO 344 SF
GARAGE 598 SF
HEIGHT ALLOWED: 29'
PROVIDED: 22'-6" +/-

SET BACKS: Required FRONT 25'
REAR 10'
SIDE 20% Frontage = 21'
Provided FRONT 25'-2"
REAR 12'-11"
SIDE 10' and 18'-4"

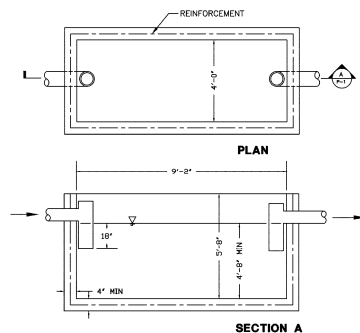

SEPTIC TANK DETAIL 1050 GAL

N.T.S.

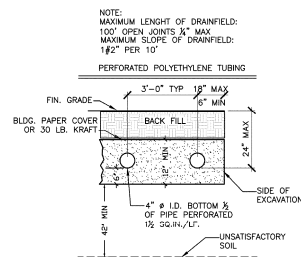

DRAINFIELD DETAIL

N.T.S.

LEGAL DESCRIPTION

LOTS 7 AND 8, BLOCK 264, OF REVISED PLAT OF CORAL GABLES, RIVERA SECTION, PART 11, ACCORDING TO THE PLAT THEREOF, RECORDED IN PLAT BOOK 28, PAGE 23, OF THE PUBLIC RECORDS OF MIAMI-DADE COUNTY, FLORIDA


PROPERTY ADDRESS: 6510 SAN VICENTE STREET, CORAL GABLES, FL 33146

STATEMENT OF COMPLIANCE

TO THE BEST OF MY KNOWLEDGE THESE DRAWINGS AND THE PROJECT MANUAL ARE COMPLETE, AND COMPLY WITH THE FLORIDA BUILDING CODE, 2010.

SEPTIC TANK AND DRAIN FIELD CALCULATIONS

LIVING AREA			2914.00	SF	
3 BED ROOM			2250.00	SF	300.00 GAL/DAY
ADDITIONAL SF	750.00	SF OR FRACTION	664.00	SF	100.00 GAL/DAY
TOTAL					400.00 GAL/DAY
AREA OF DRAIN FIELD	0.60		667	SF	
Unobstructed Area	0.50		333	SF	
			1000.00	SF	
SEPTIC TANK	400.00	GAL	1050.00	GALLON TANK	TABLE II

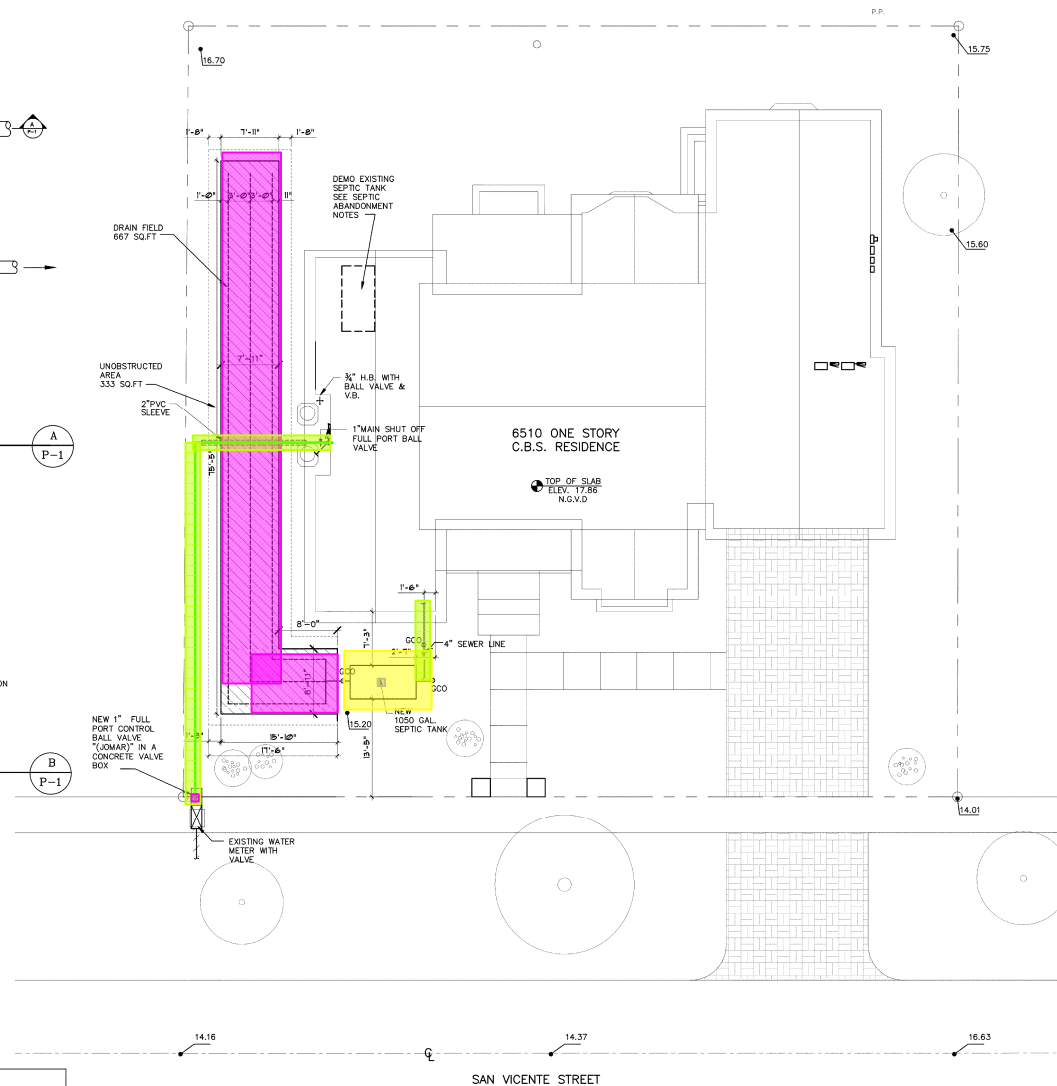

PLUMBING SITE PLAN

SCALE: 1/8" = 1'-0"

EBBERT RESIDENCE
BFA-JOB 14032

BHAMANI, FORD, & ASSOCIATES INC.
CONSULTING ENGINEERS & PLANNERS
4900 N.W. 14 COURT, MIAMI, FLORIDA 33155
1305-953-1964, 953-6392, FAX 1305-957-9093

THOMAS H. MAXWELL, JR., P.E.
FLORIDA P.E. LICENSE NO. 10150



7450 Southwest 48th Street
Miami, Florida 33155
Phone (305) 661-5392
Fax (305) 661-5832
info@architektnics.com
License # AAC000546

www.architektnics.com

NEW RESIDENCE FOR:
MARLIN EBBERT
6510 SAN VICENTE STREET
CORAL GABLES, FLORIDA 33146

Project

Scale

Edward C. Beroumly, RA,
License Number: AR000433

Drawing title:

PLUMBING
SITE PLAN
SEPTIC TANK

Issue Date: 10-DEC-14

Revisions:

Job No.: 14107
Drawn By:
Sheet No.:

P-1

- Gas - PVC Gas Piping 137 LF
- VTR 50 LF
- Waste Piping 526 LF
- Gas - Main Shut off Valve 1 EA
- Gas - Distribution Box 1 EA
- Gas - Pressure Regulator 1 EA
- Gas - 50 GAL GAS TANK 1 EA



7450 Southwest 48th Street
Miami, Florida 33155
Phone (305) 661-5392
Fax (305) 661-5832
info@architeknics.com
License # AAC00546

www.architeknics.com

NEW RESIDENCE FOR
MARLIN EBBERT
6910 SAN VICENTE STREET
CORAL GABLES, FLORIDA 33146

Project

Scal


Edward C. Beroumky, RA
License Number: 14032

Drawing title:
**PLUMBING
SANITARY & GAS
FLOOR PLAN**

Issue Date:	10-DEC-14
Revisions:	

Job No.:	14107
Drawn By:	
Sheet No.:	P-2
	OF 5

PLUMBING LEGEND			
SYMBOL	DESCRIPTION	SYMBOL	DESCRIPTION
---	NATURAL GAS LINE	---	PRESSURE & TEMP RELIEF
---	NEW COLD WATER LINE	⌈	AIR ADMITTANCE VALVE
---	NEW HOT WATER LINE	⌋	AIR CHAMBER
----	EXIST. SANITARY LINE	+	HOSE BIBB WITH VALVE AND VACUUM BREAKER
---	NEW SANITARY LINE	⌋	GAS FILLED
----	EXIST. NATURAL GAS LINE	VTR	VENT THROUGH ROOF
---	NEW SANITARY VENT LINE	○	PIPE UP
○○○	GRADE CLEAN OUT TWO WAY	⌋	PIPE DOWN
---	BALL VALVE	---	FULL PORT BALL VALVE
---	GATE VALVE	WC	WATER CLOSET
---	UNION	KS	KITCHEN SINK
---	CLEAN OUT	SHO/TUB	SHOWER/TUB
---	CONDENSATE DRAIN LINE	DW	DISH WASHER
HB	HOSE BIBB	LAV	LAVATORY
WM/DR	WASHING MACHINE/DRYER	WH	WATER HEATER
VB	VACUUM BREAK	REF	REFRIGERATOR

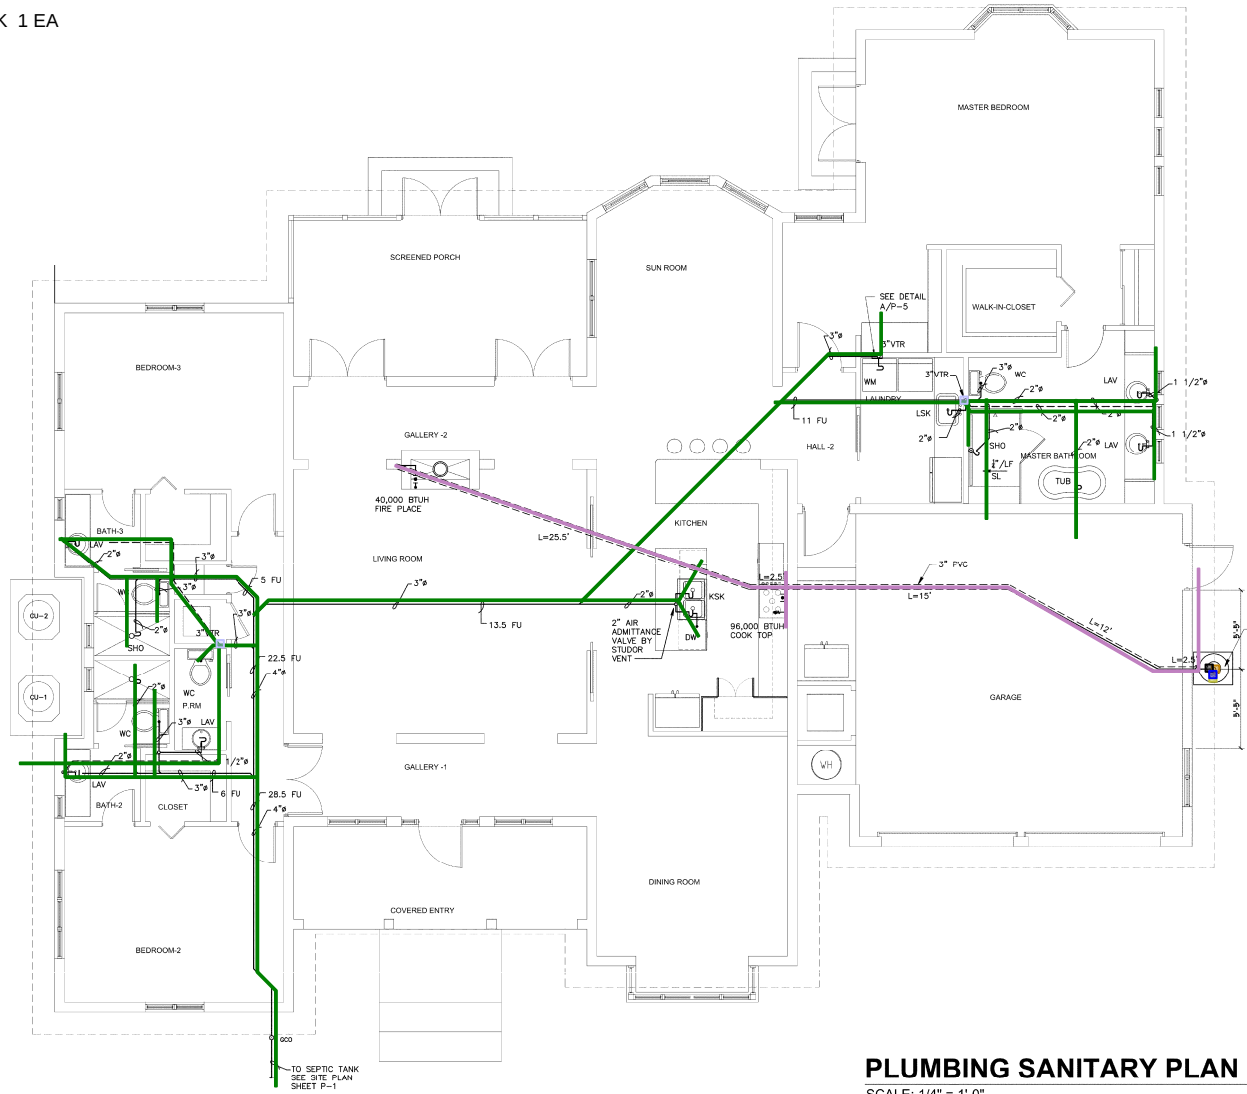

PLUMBING SANITARY PLAN
SCALE: 1/4" = 1'-0"



EBBERT RESIDENCE
BFA-JOB 14032

THOMAS H. MAYWELL, JR., P.E.
FLORIDA P.E. LICENSE NO. 10190

BHAMANI, FORD & ASSOCIATES INC.
CONSULTING ENGINEERS & PLUMBERS
4300 NW 74 COURT, MIAMI, FLORIDA 33188
(305) 555-9854, (305) 555-9855 FAX (305) 555-9855

-
- ELEVATION**
- SCALE 1"=1'-0"
- EA
570 LF
CU-2
CU-1
WH-2
1" MAIN SHUT BALL VALVE
CONC. SLAB
- Dimensions: 2", 2'-6", 2", 6", 1'-3", 6", 3", 4", 3'-1", 1'-8", 3'-1", 1'-0"
- Labels: EA, 570 LF, CU-2, CU-1, WH-2, 1" MAIN SHUT BALL VALVE, CONC. SLAB



N.T.S.

A
P-3

SCALE: 1/4" = 1'-0"



BHAMANI, FORD, & ASSOCIATES INC.
CONSULTING ENGINEERS & PLANNERS
4900 N.W. 74 COURT, MIAMI, FLORIDA 33155
(305) 983-1954, 983-8380, FAX (305) 987-5003

Job No.: 14107
 Drawn By:
 Sheet No.:
P-3
 OF 5



OF 5